


WHO REFURBISHMENT DRAWINGS

FLOOR PLANS

24-11-2025

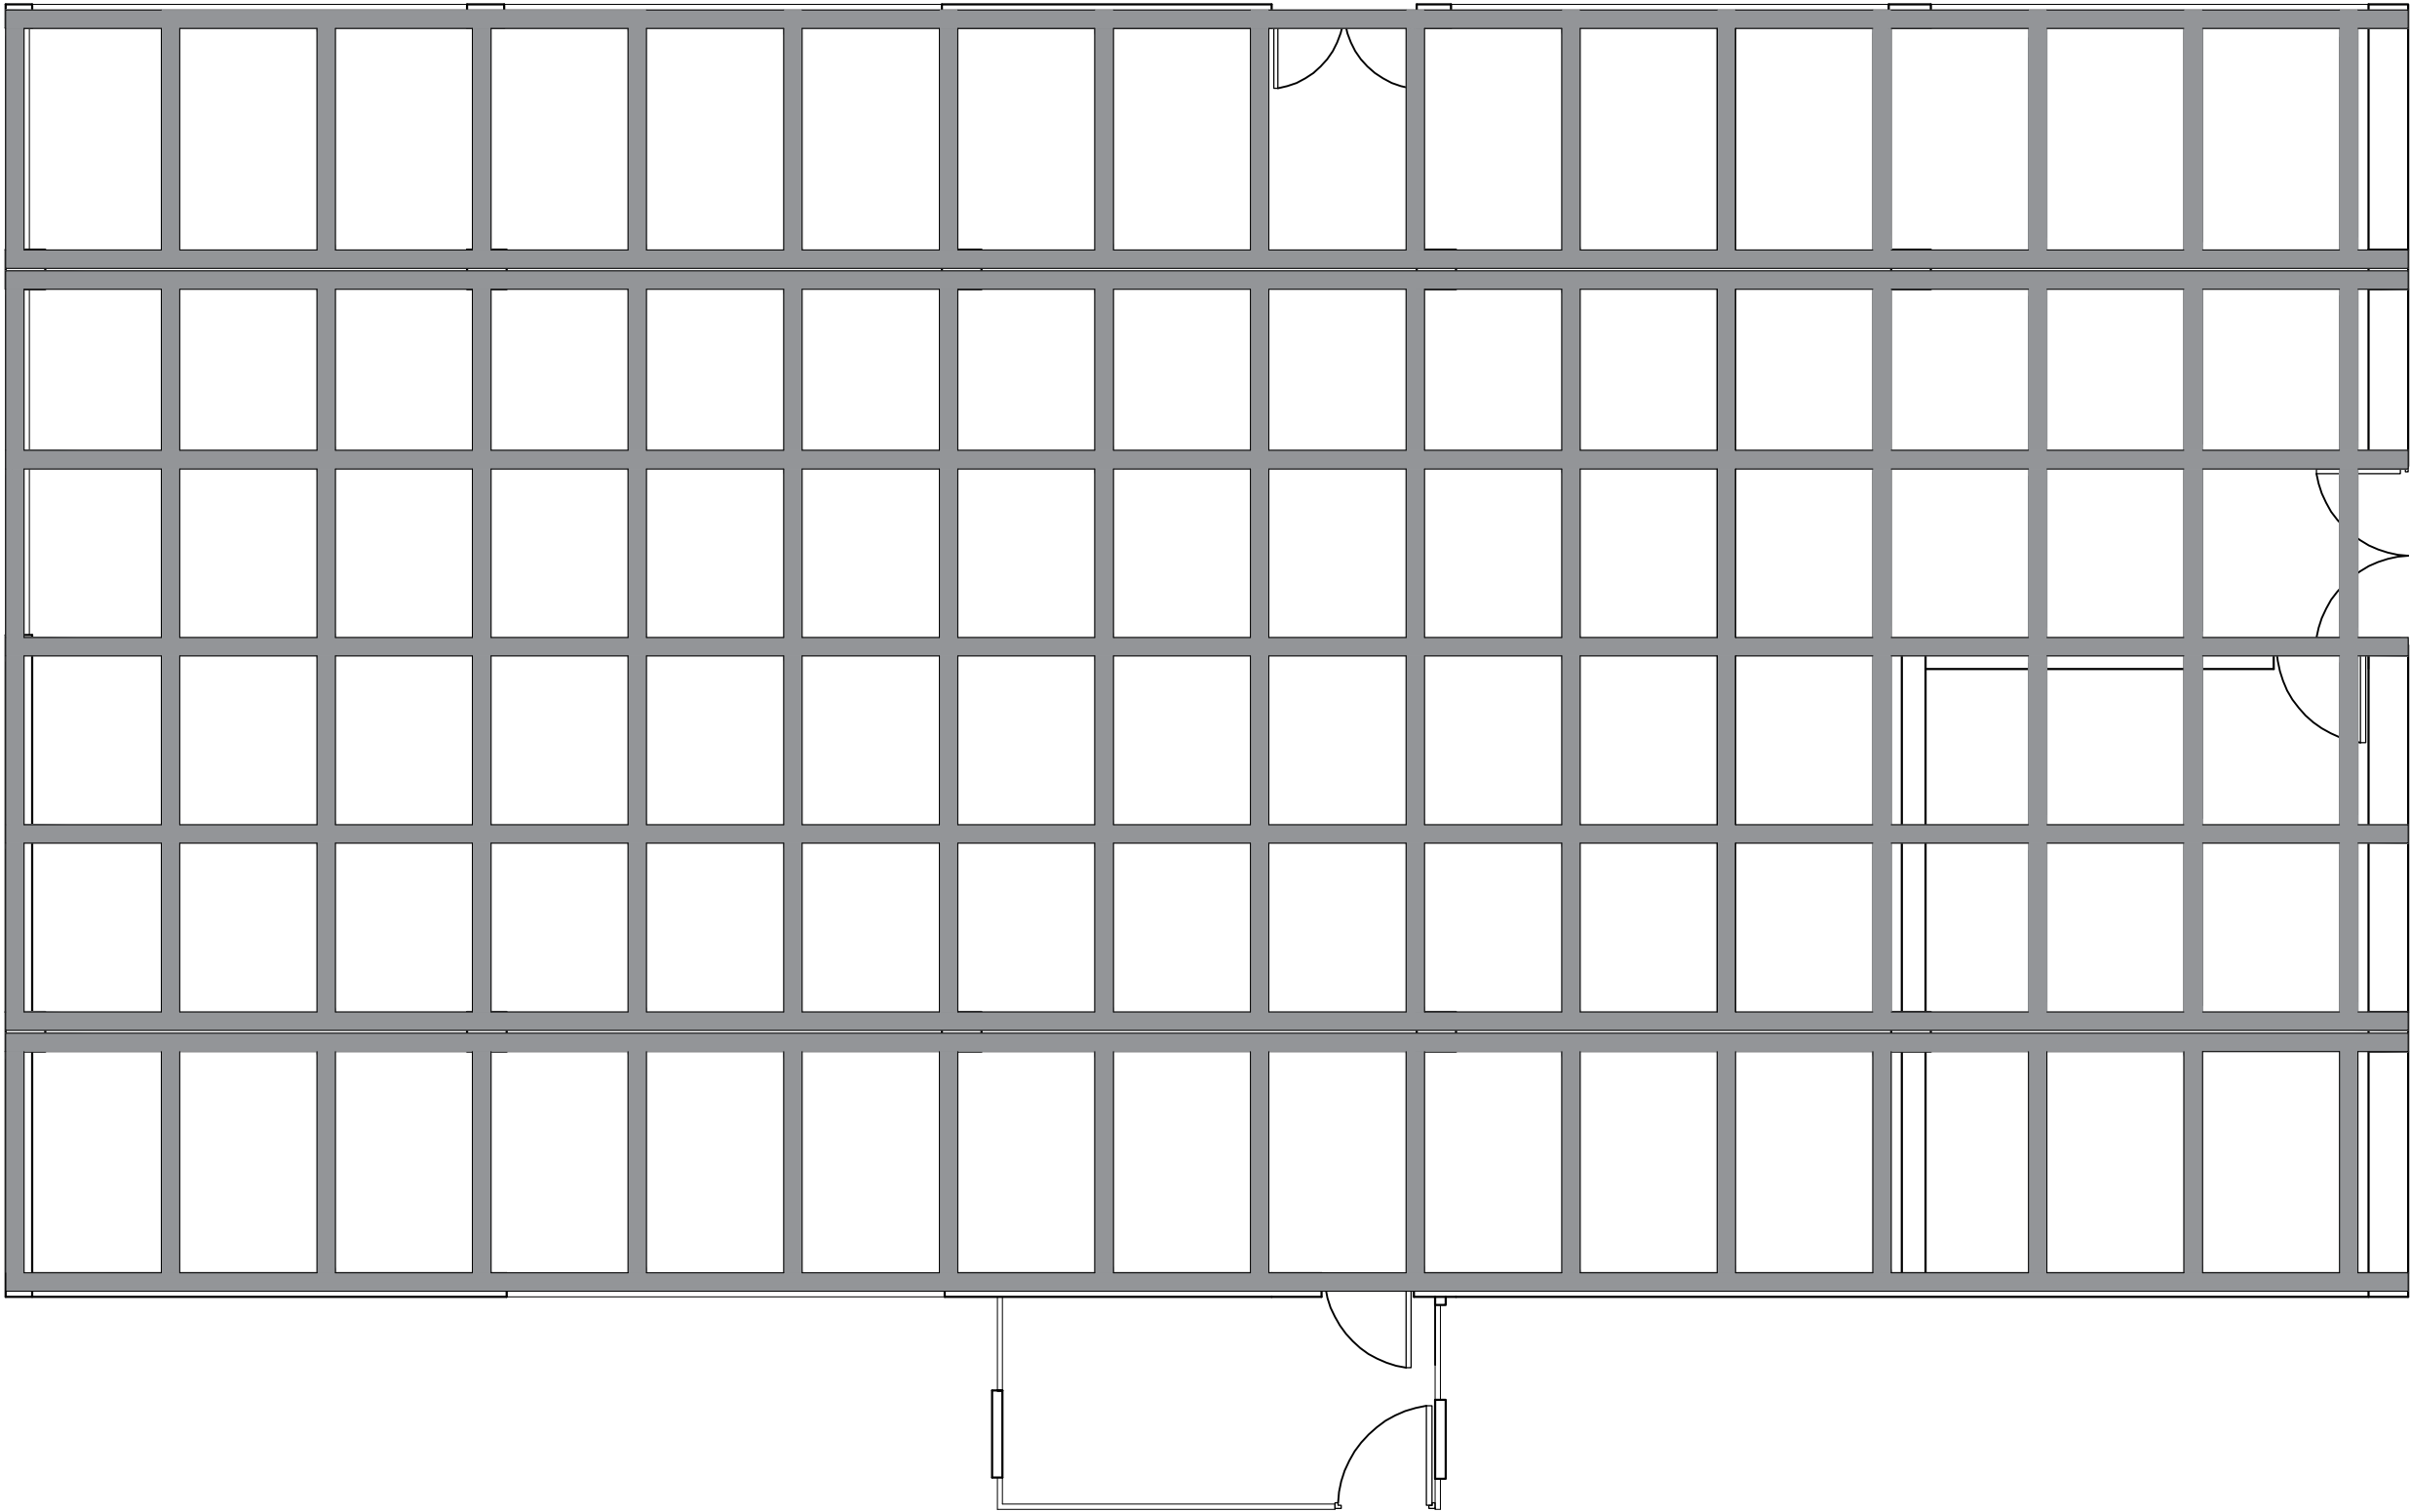

BEAM PLAN SCALE= 1:100

WHO OFFICE

Project Location

UN House
Pulchowk, Lalitpur

Project Type

Design

Project Architect

Drawn By

Note

Sheet Title


BEAM PLAN

Date

NOVEMBER, 2025

A-102

Sheet No.

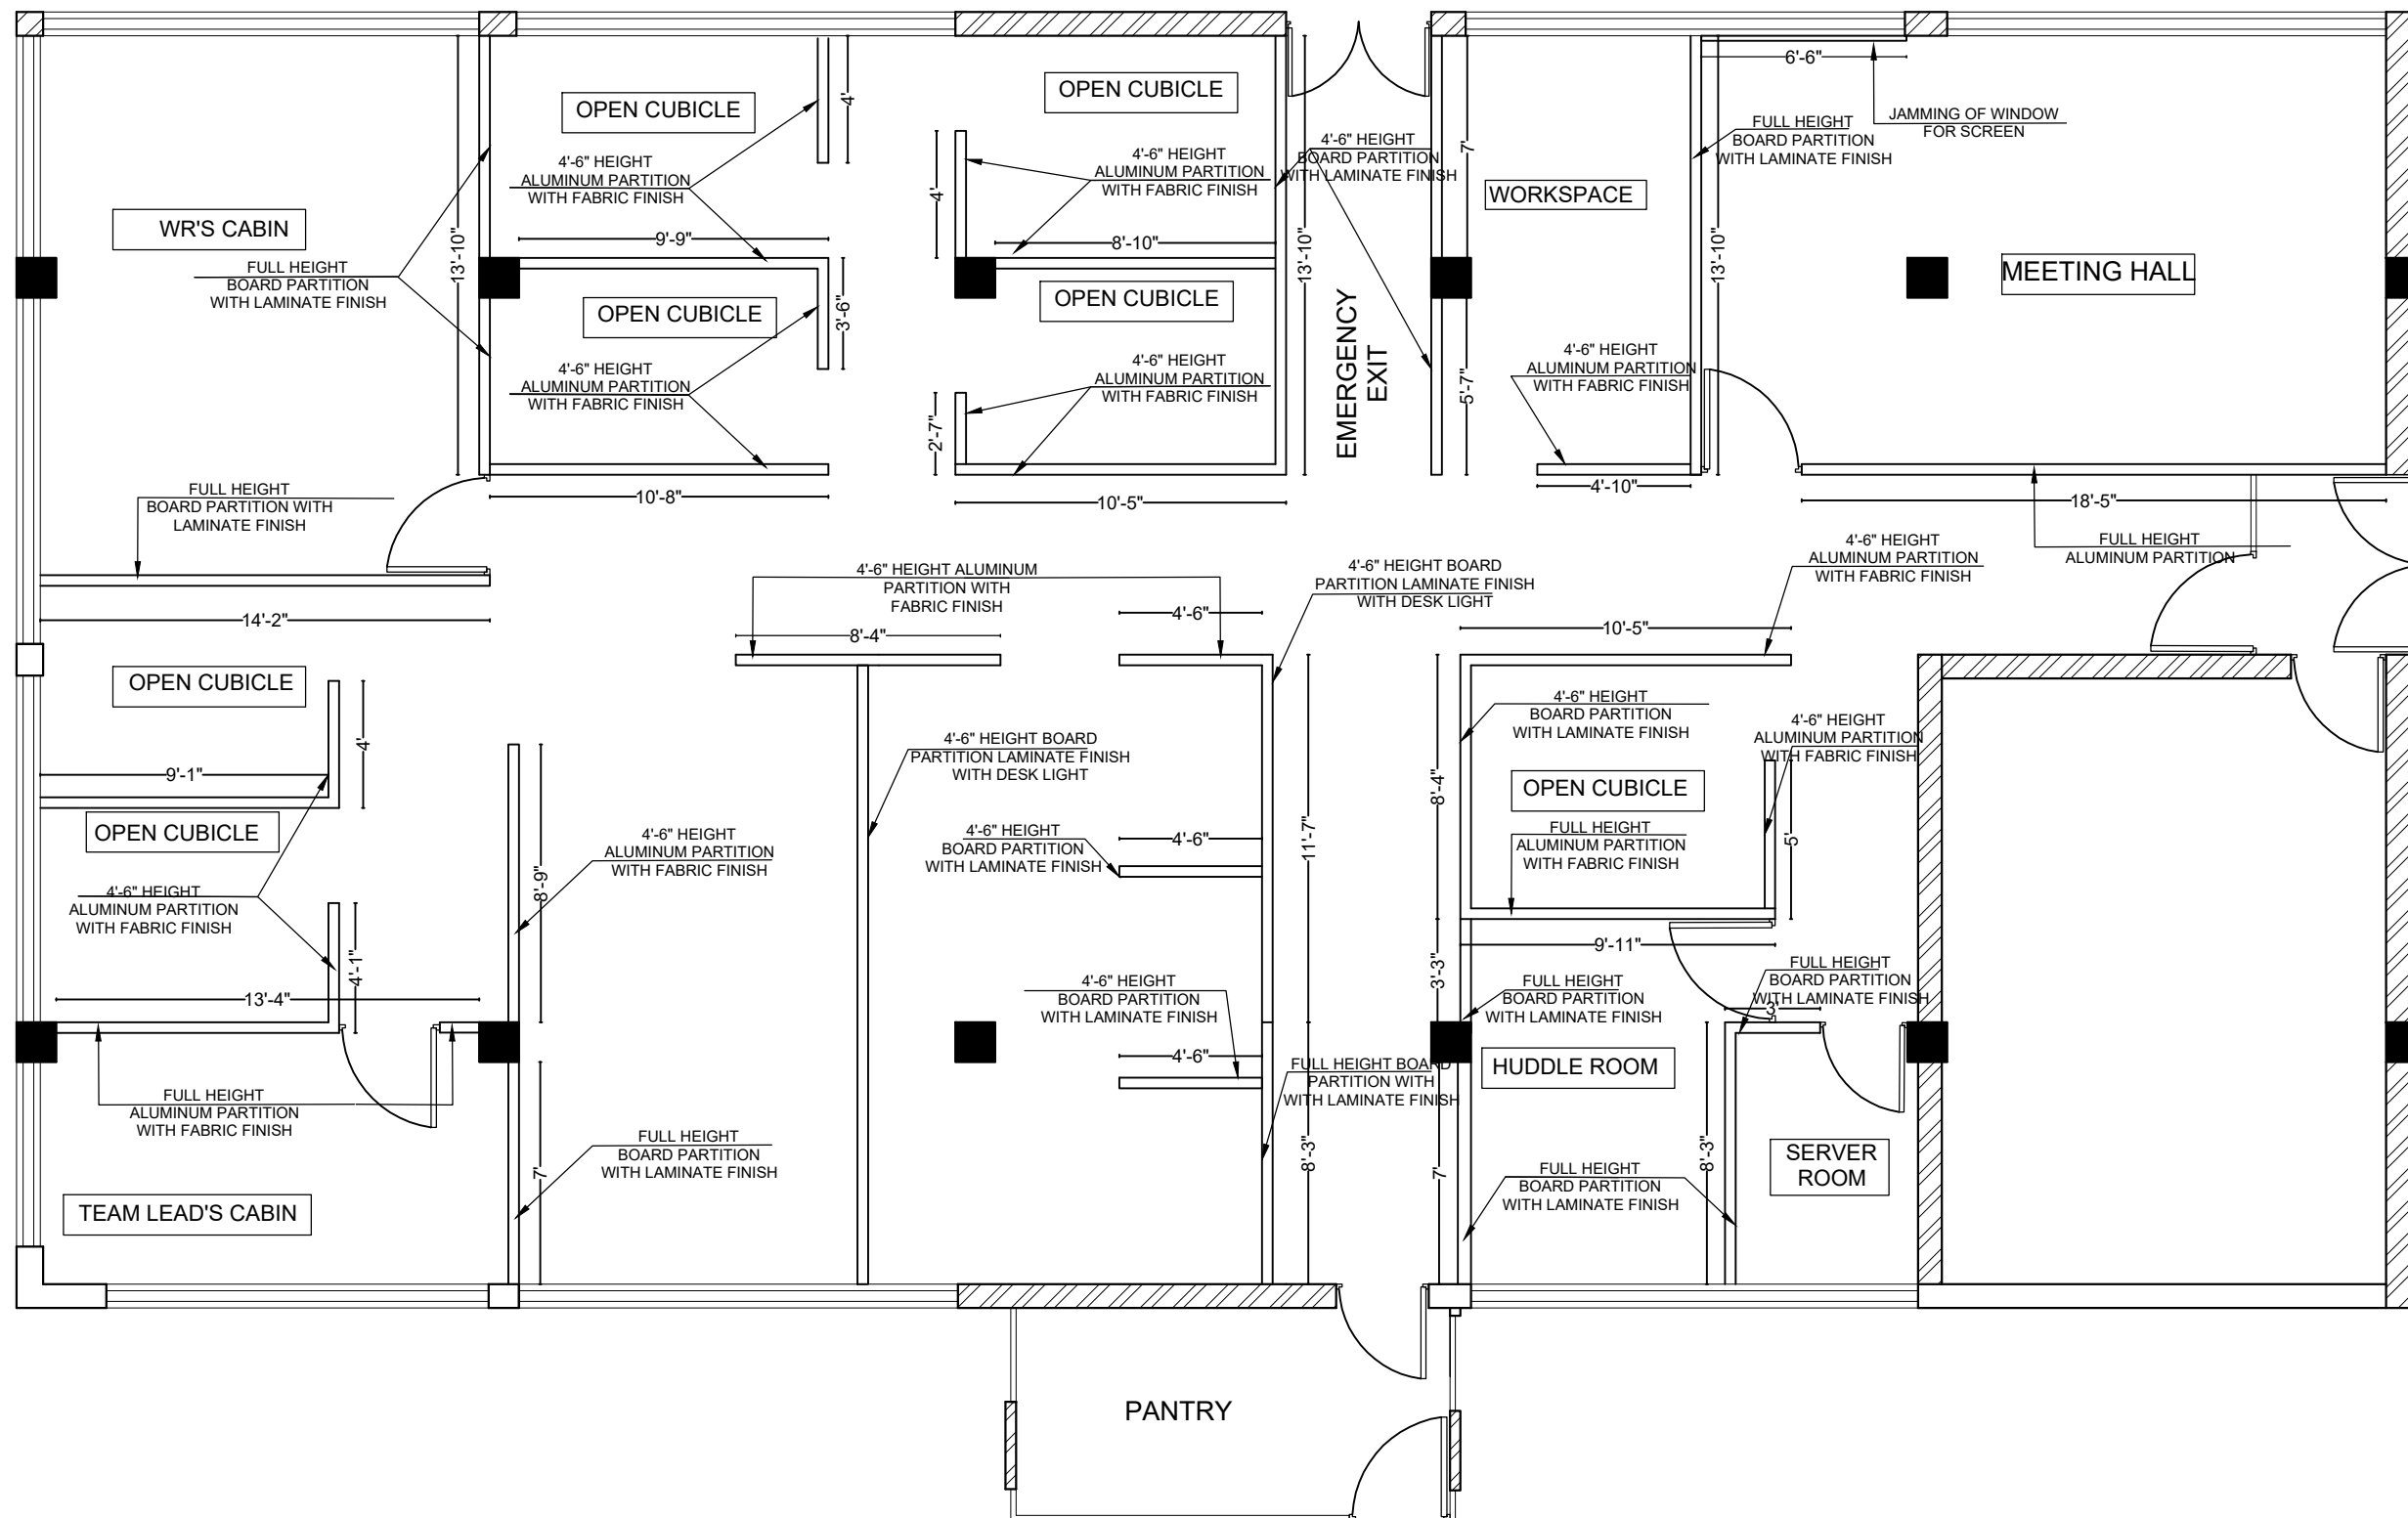

PARTITION LAYOUT PLAN SCALE= 1:100

Project Location

UN House
Pulchowk, Lalitpur

Project Type

Design

Project Architect

Drawn By

Note

Sheet Title


PARTITION LAYOUT PLAN

Date

NOVEMBER, 2025

A-103

Sheet No.

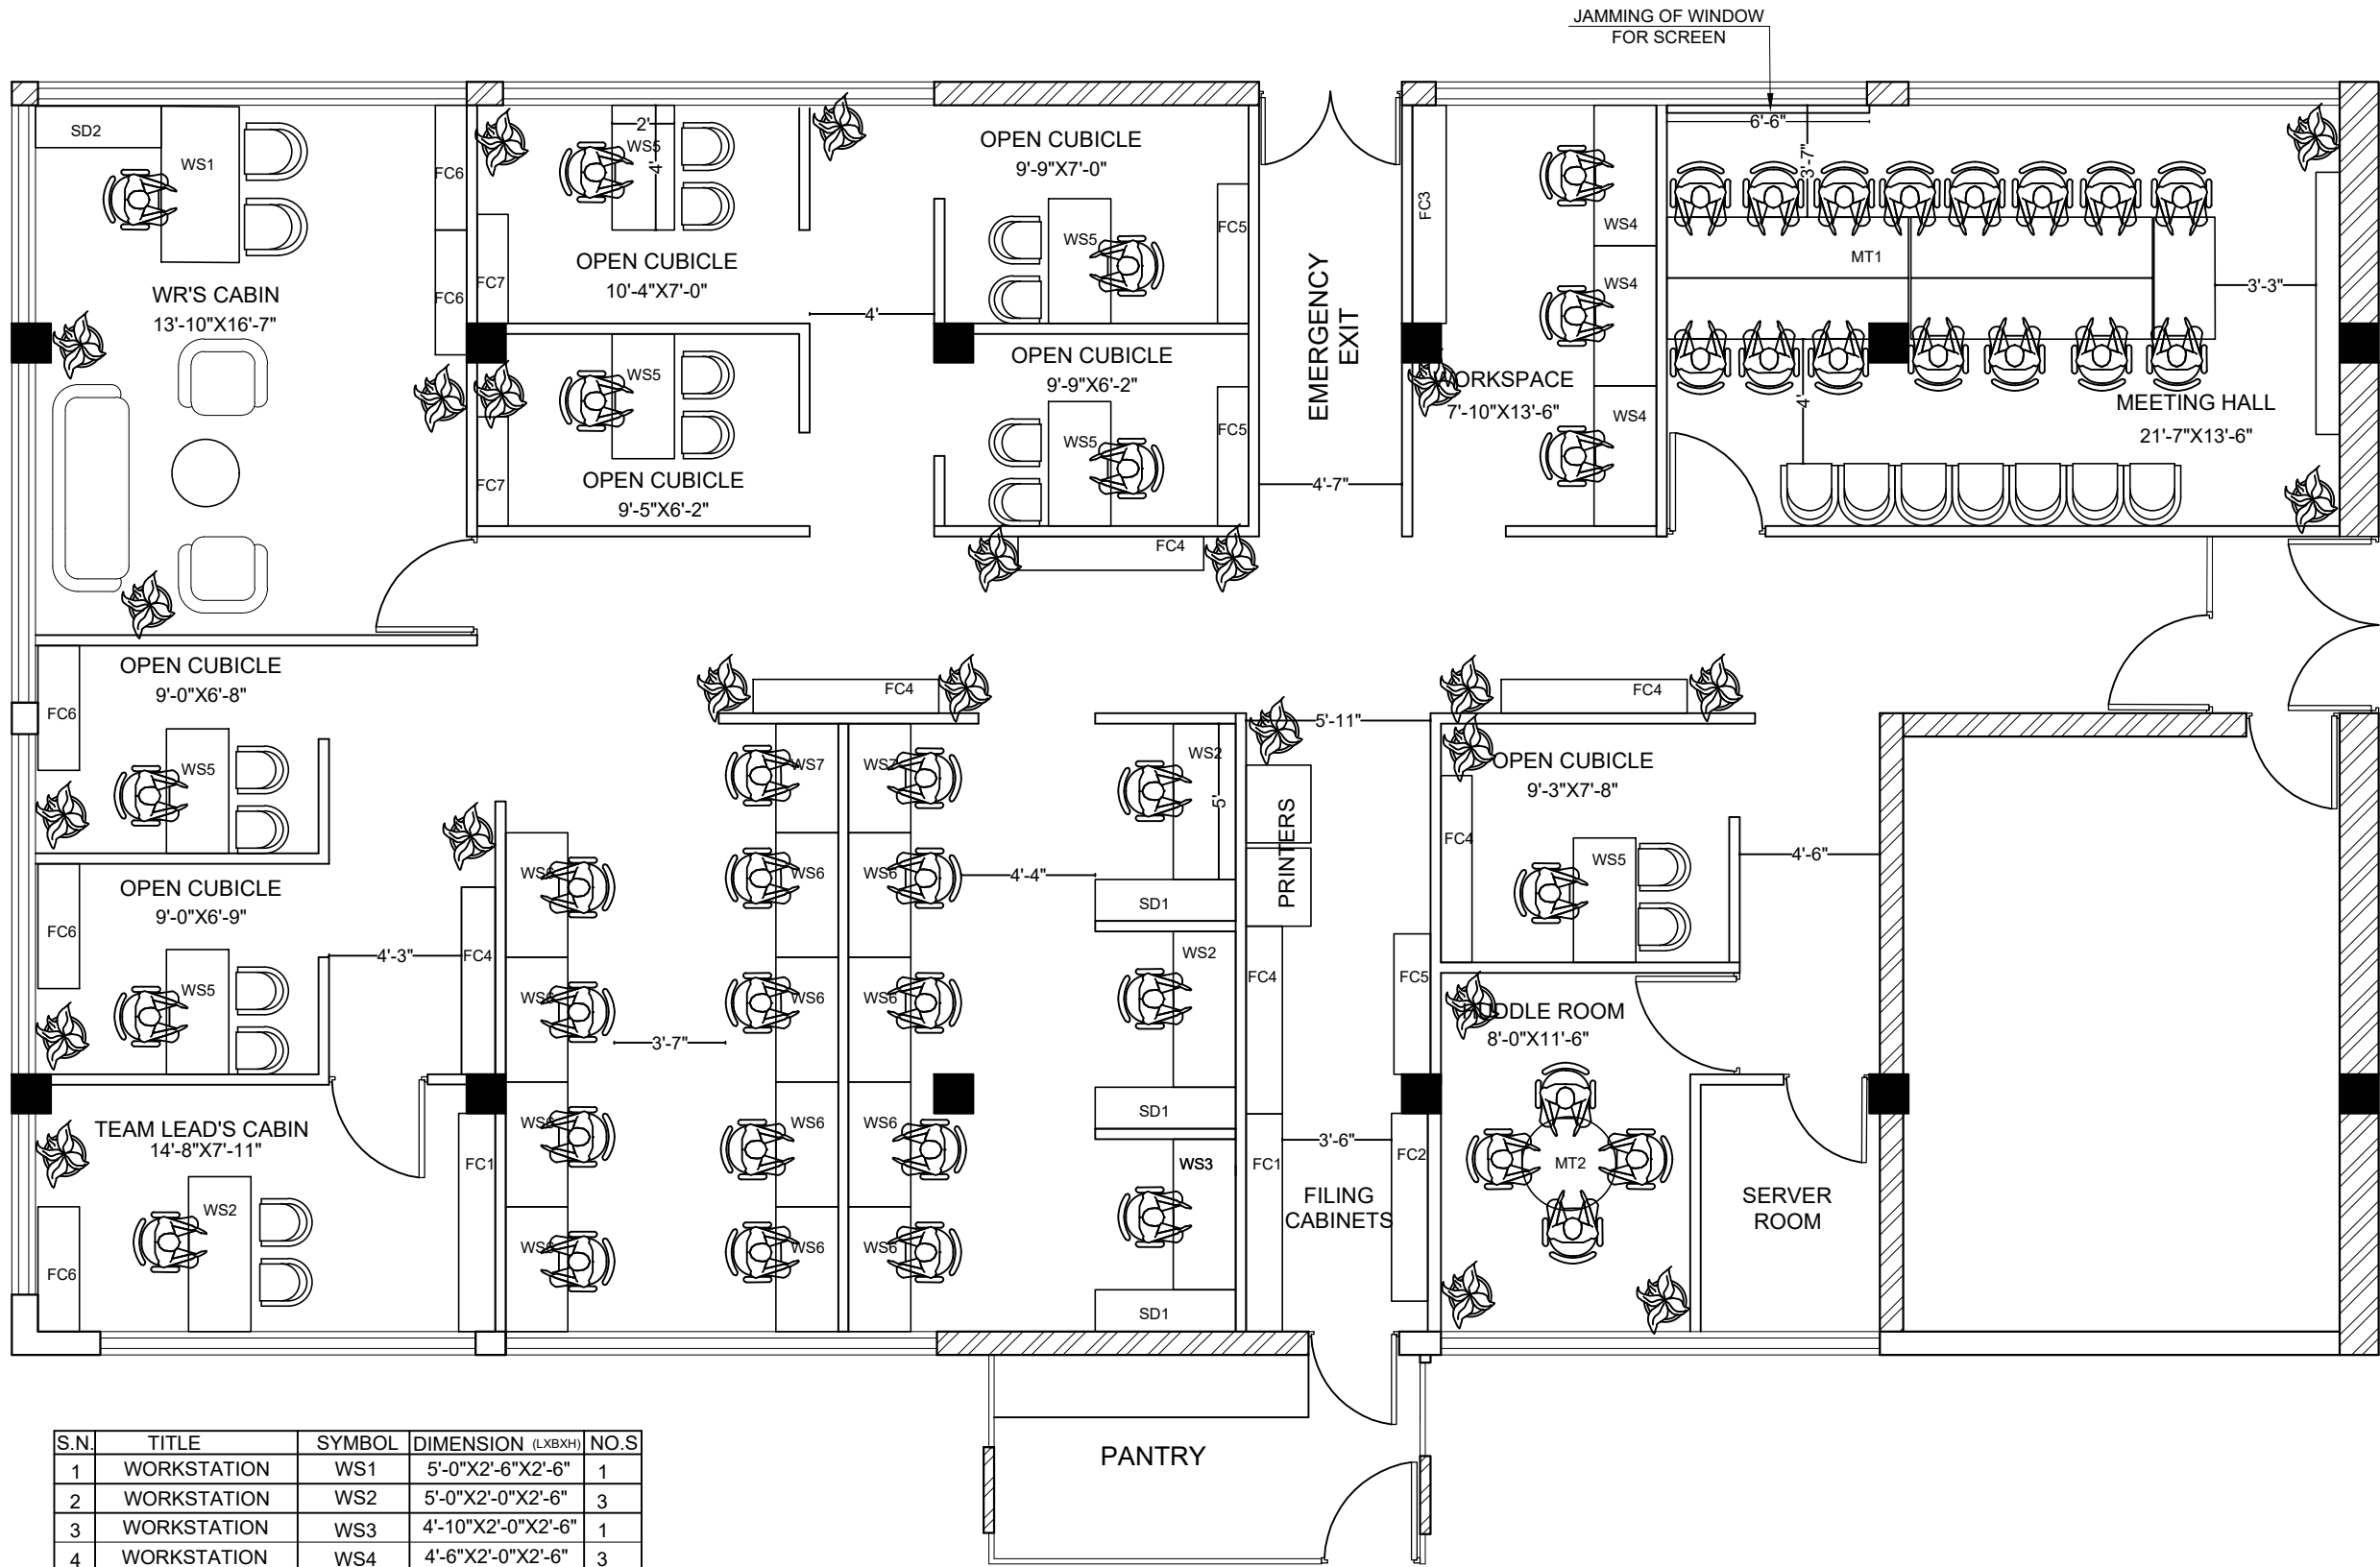

S.N.	TITLE	SYMBOL	DIMENSION (LXBXH)	NO.S
1	WORKSTATION	WS1	5'-0"X2'-6"X2'-6"	1
2	WORKSTATION	WS2	5'-0"X2'-0"X2'-6"	3
3	WORKSTATION	WS3	4'-10"X2'-0"X2'-6"	1
4	WORKSTATION	WS4	4'-6"X2'-0"X2'-6"	3
5	WORKSTATION	WS5	4'-0"X2'-0"X2'-6"	7
6	WORKSTATION	WS6	4'-0"X2'-0"X2'-6"	12
7	WORKSTATION	WS7	3'-6"X2'-0"X2'-6"	2
8	SIDE DESK	SD1	4'-6"X1'-4"X2'-6"	3
9	SIDE DESK	SD2	4'-0"X1'-4"X2'-6"	1
10	FILE CABINET	FC1	7'-0"X1'-2"X9'-0"	2
11	FILE CABINET	FC2	6'-0"X1'-2"X9'-0"	1
12	FILE CABINET	FC3	7'-0"X1'-1"X3'-0"	1
13	FILE CABINET	FC4	6'-0"X1'-1"X3'-0"	6
14	FILE CABINET	FC5	4'-6"X1'-1"X3'-0"	3
15	FILE CABINET	FC6	4'-0"X1'-1"X3'-0"	5
16	FILE CABINET	FC7	3'-6"X1'-1"X3'-0"	2
17	MEETING TABLE	MT1	17'-6"X4'-0"X2'-6"	1
18	MEETING TABLE	MT2	DIA XH(3'-0"X2'-6")	1

FURNITURE LAYOUT PLAN SCALE= 1:100

Project Location

UN House
Pulchowk, Lalitpur

Project Type

Design

Project Architect

Drawn By

Note

Sheet Title


FURNITURE LAYOUT PLAN

Date

NOVEMBER, 2025

A-104

Sheet No.

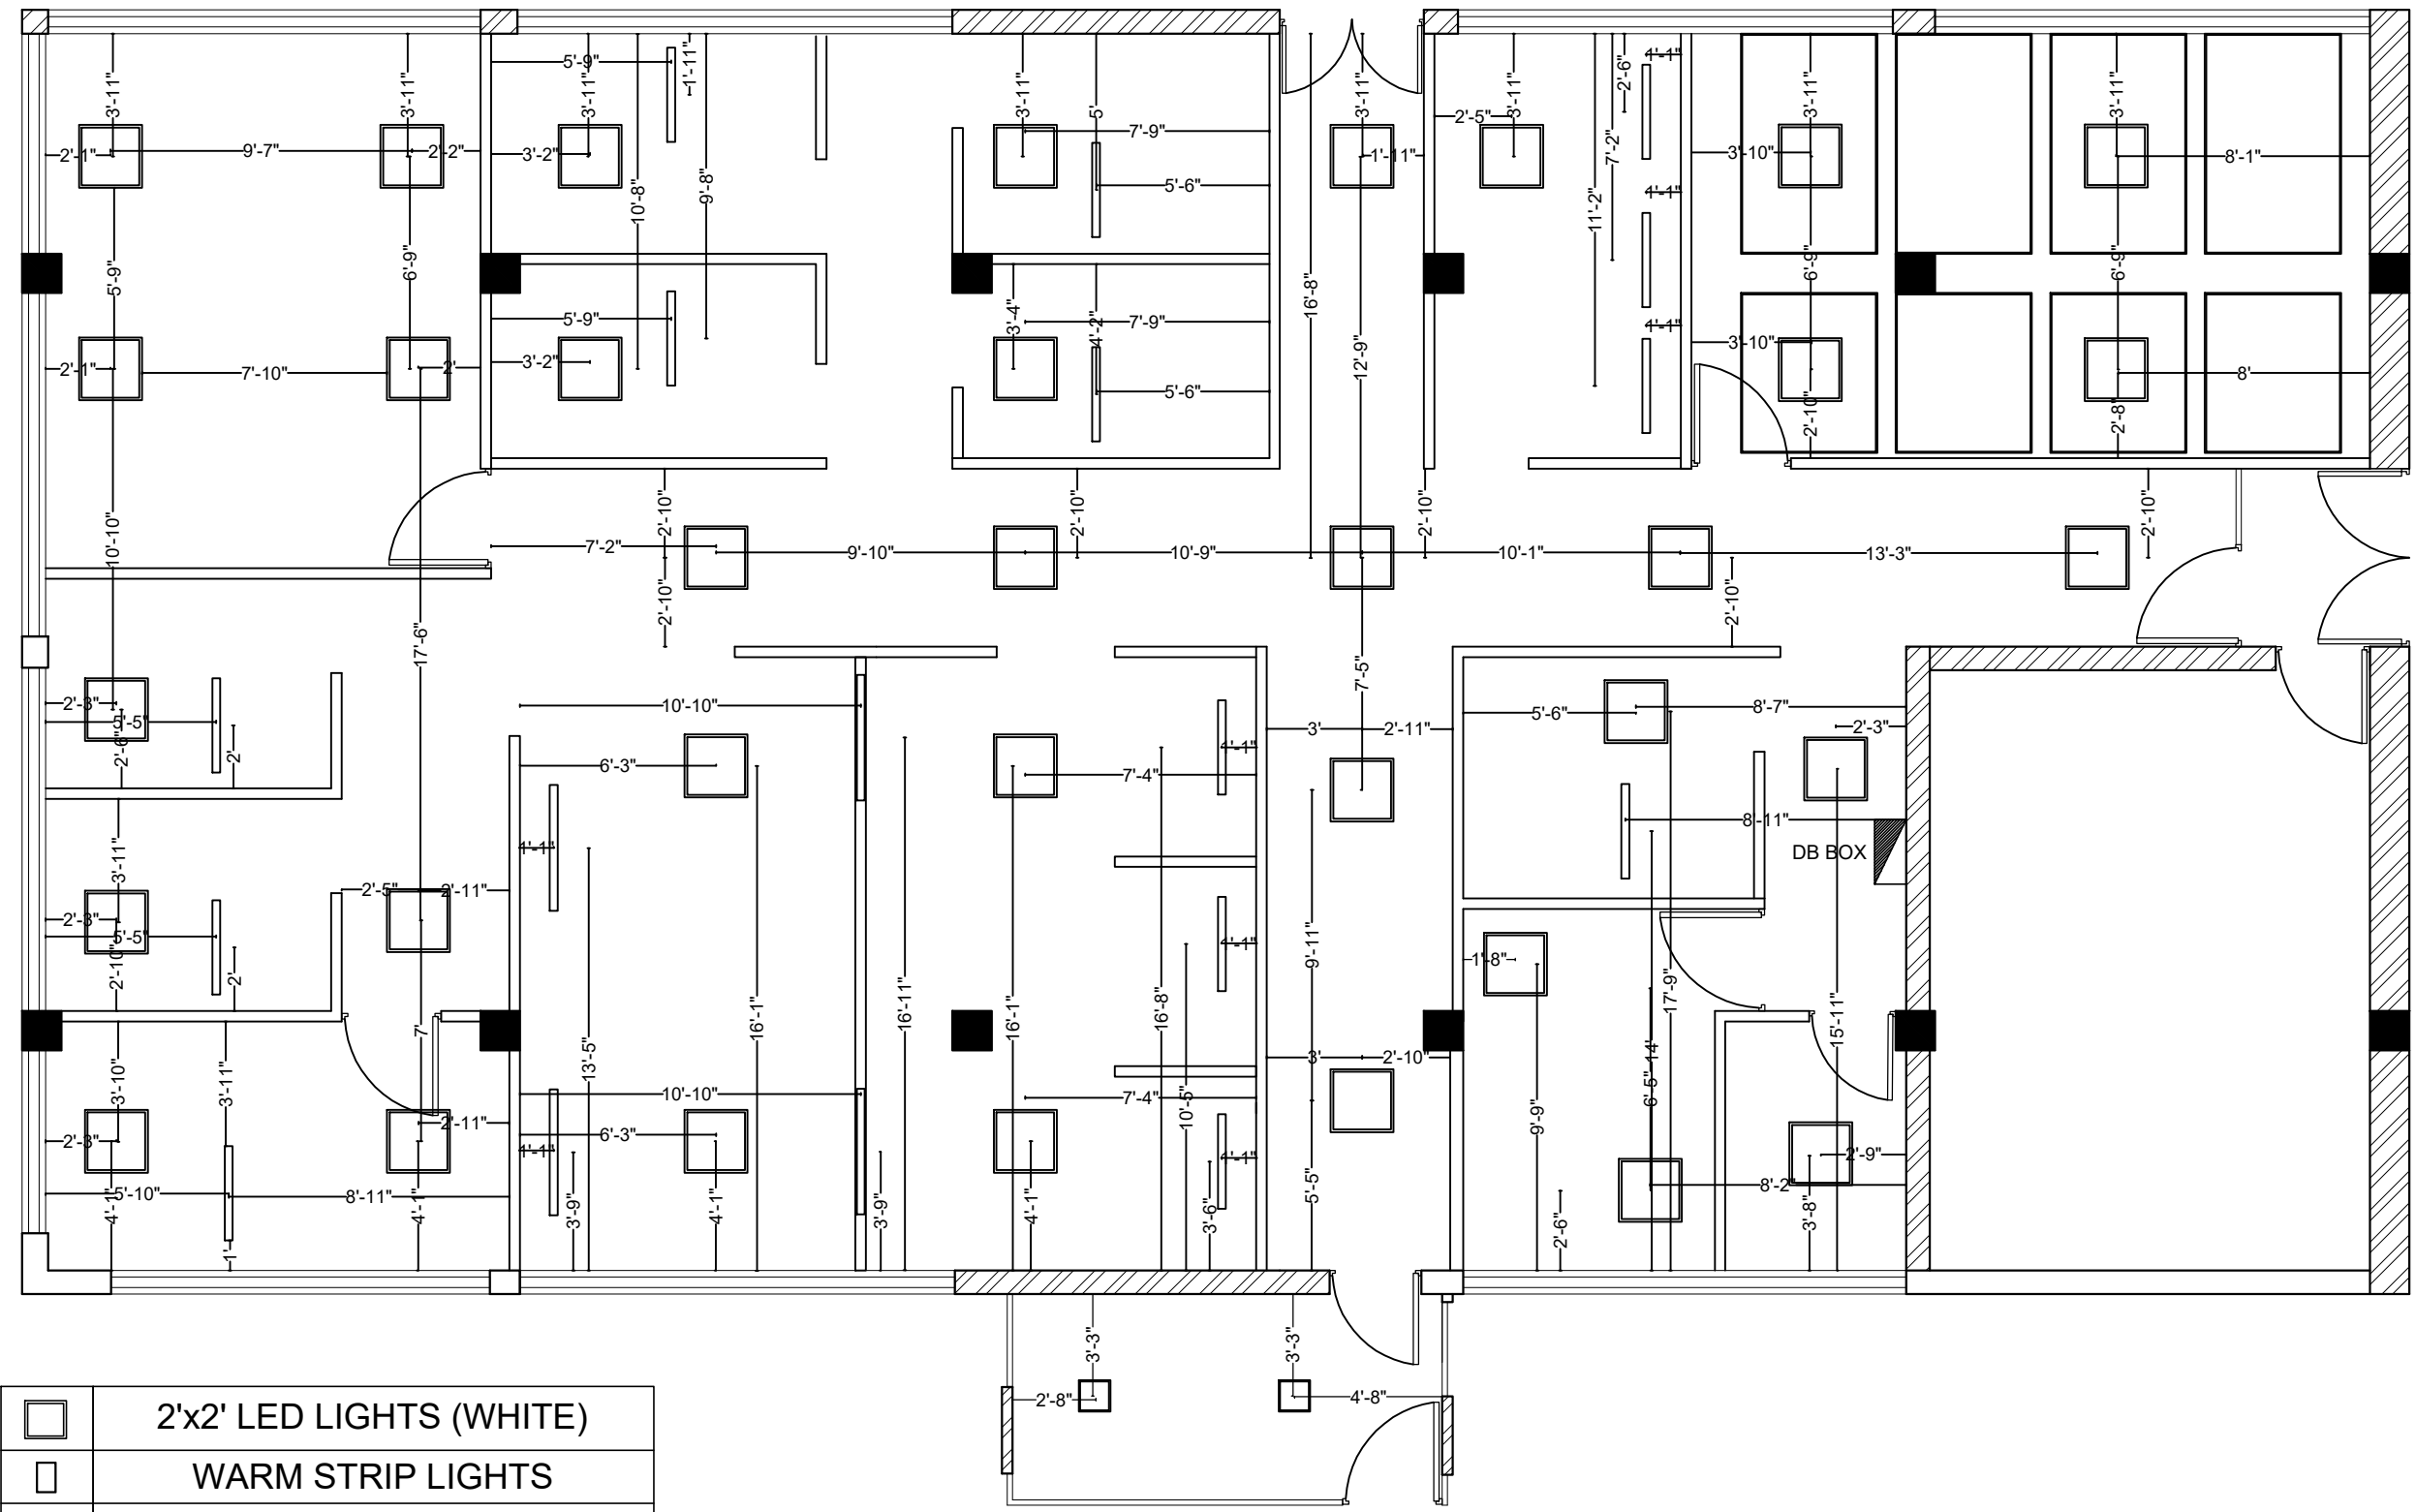

	2'x2' LED LIGHTS (WHITE)
	WARM STRIP LIGHTS
	4' LENGTH HANGING LIGHTS

LIGHTS LAYOUT PLAN SCALE= 1:100

WHO OFFICE

Project Location

UN House
Pulchowk, Lalitpur

Project Type

Design

Project Architect

Drawn By

Note

Sheet Title


LIGHTS LAYOUT PLAN

Date

NOVEMBER, 2025

A-106

Sheet No.

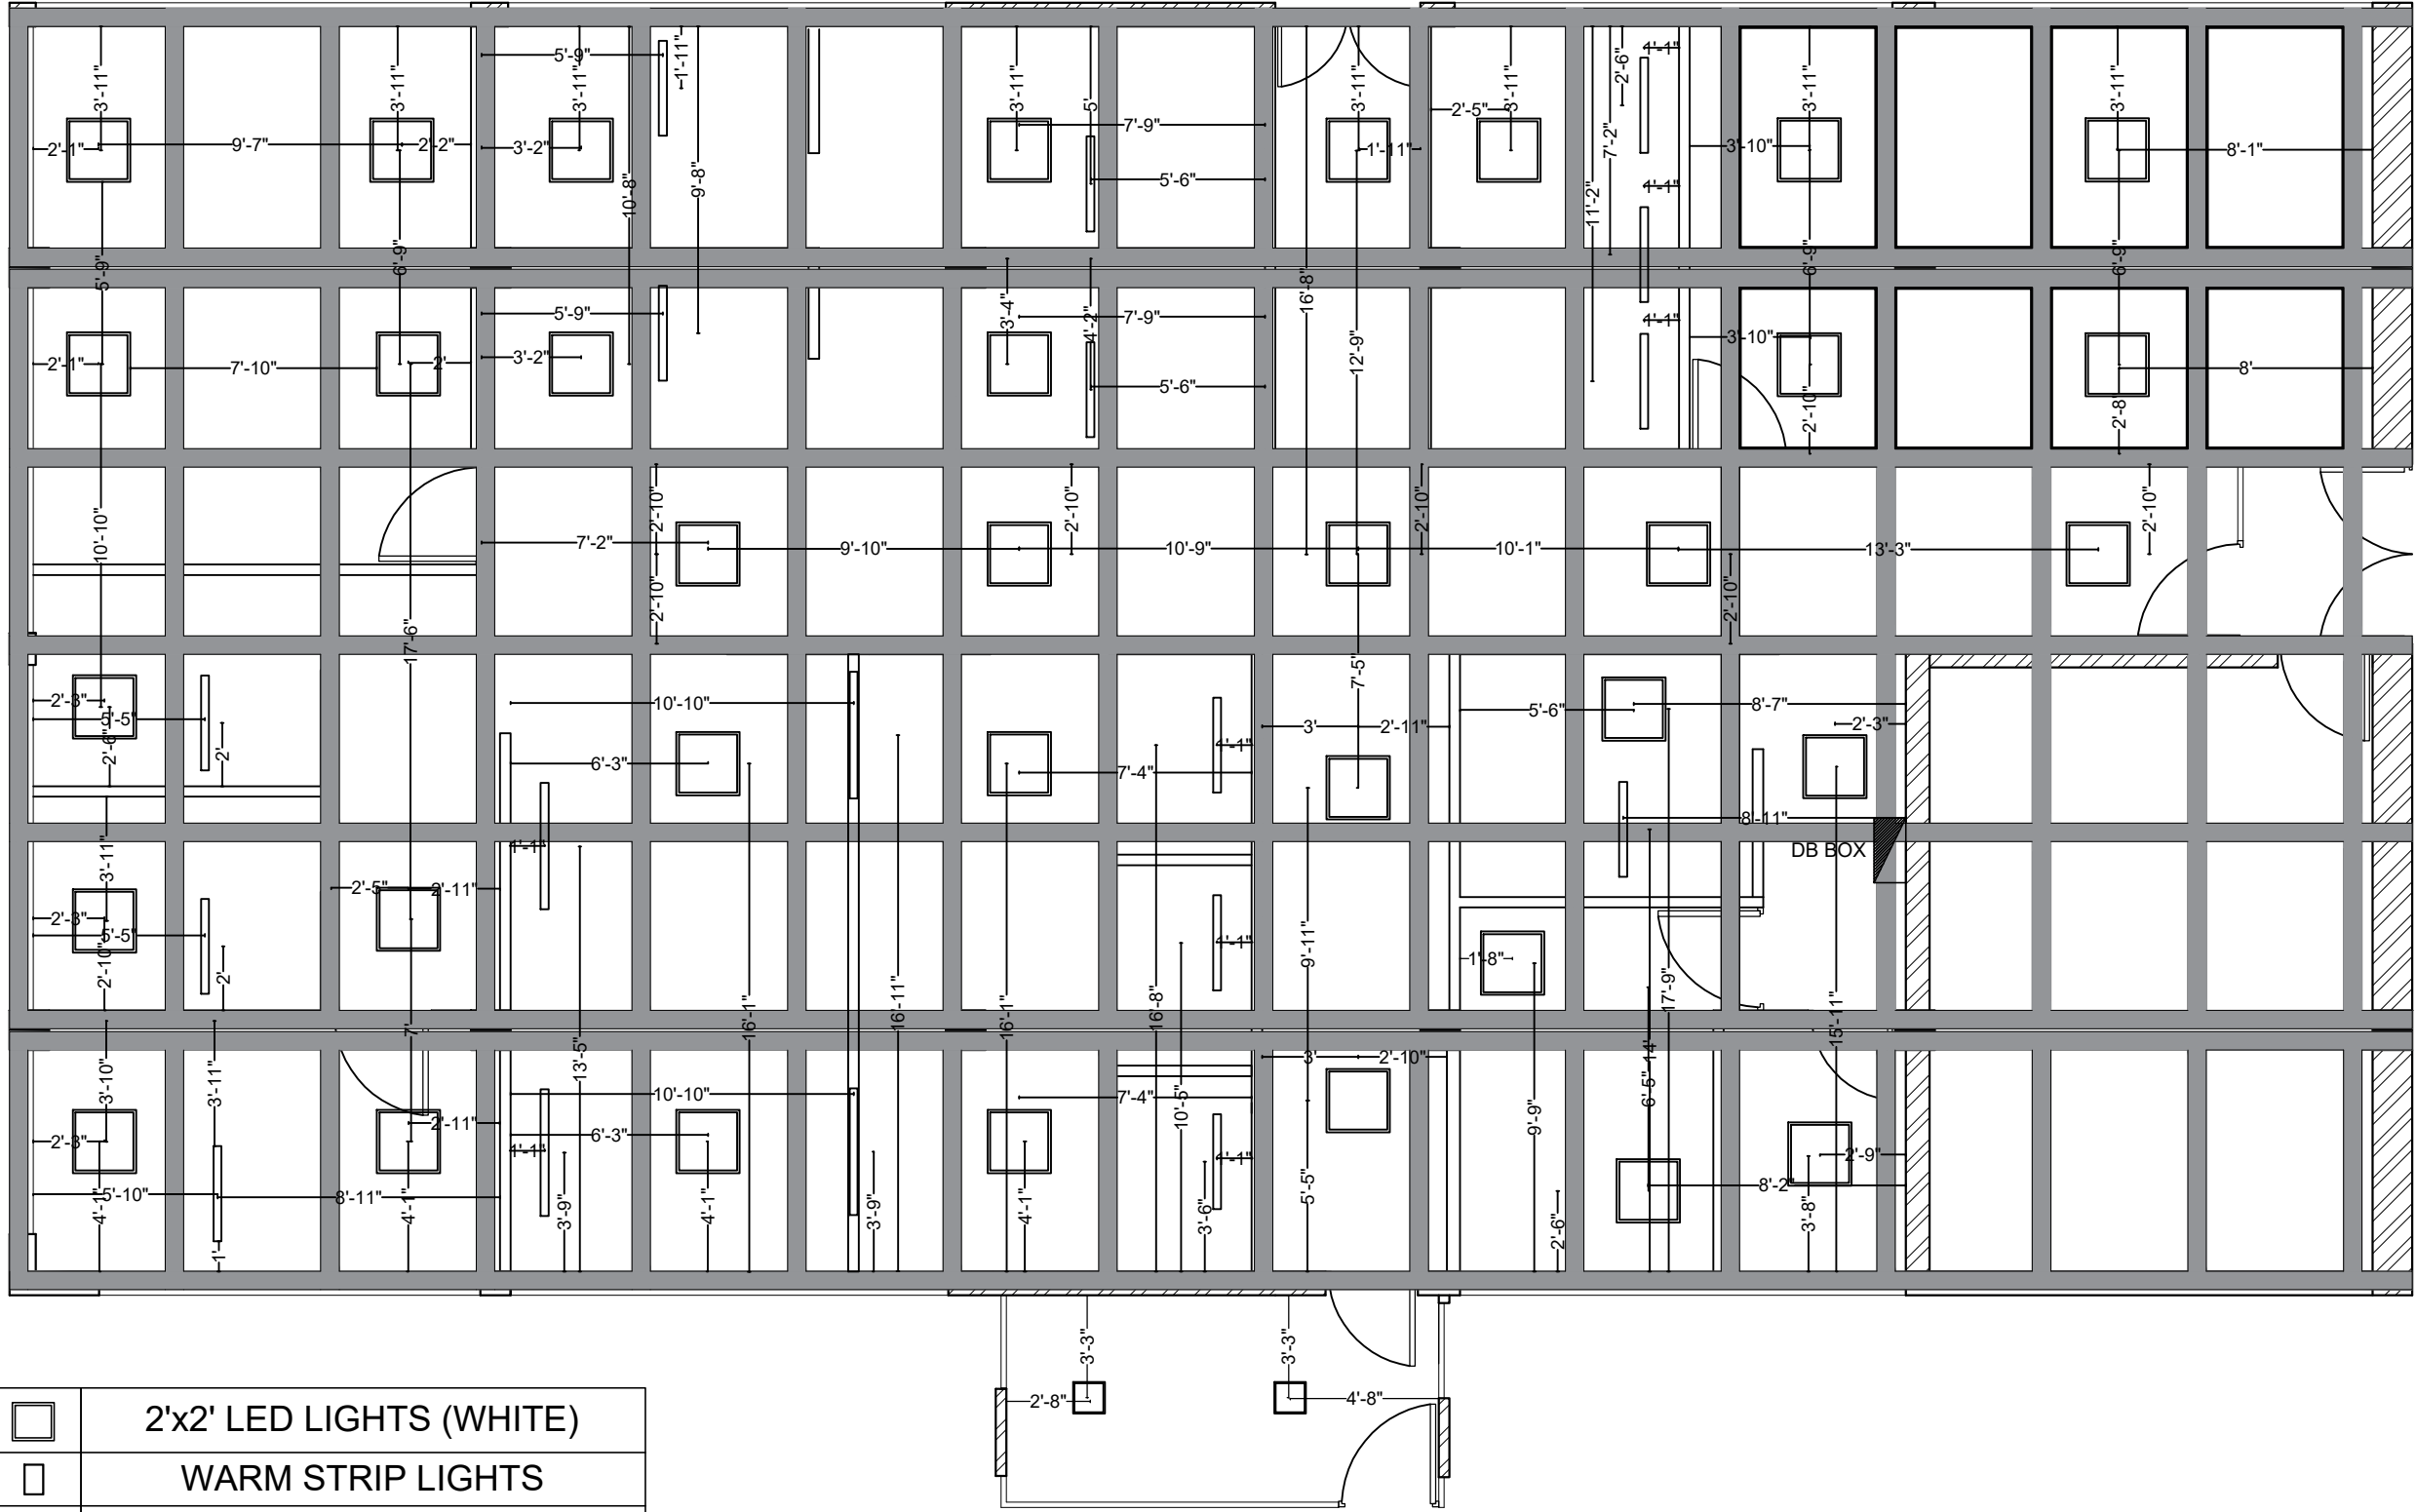

	2'x2' LED LIGHTS (WHITE)
	WARM STRIP LIGHTS
	4' LENGTH HANGING LIGHTS

LIGHTS LAYOUT PLAN SCALE= 1:100

Project Location
UN House
Pulchowk, Lalitpur

Project Type
Design

Project Architect


Drawn By

Note

Sheet Title
LIGHTS LAYOUT PLAN
WITH BEAM

Date
NOVEMBER, 2025

A-106'
Sheet No.

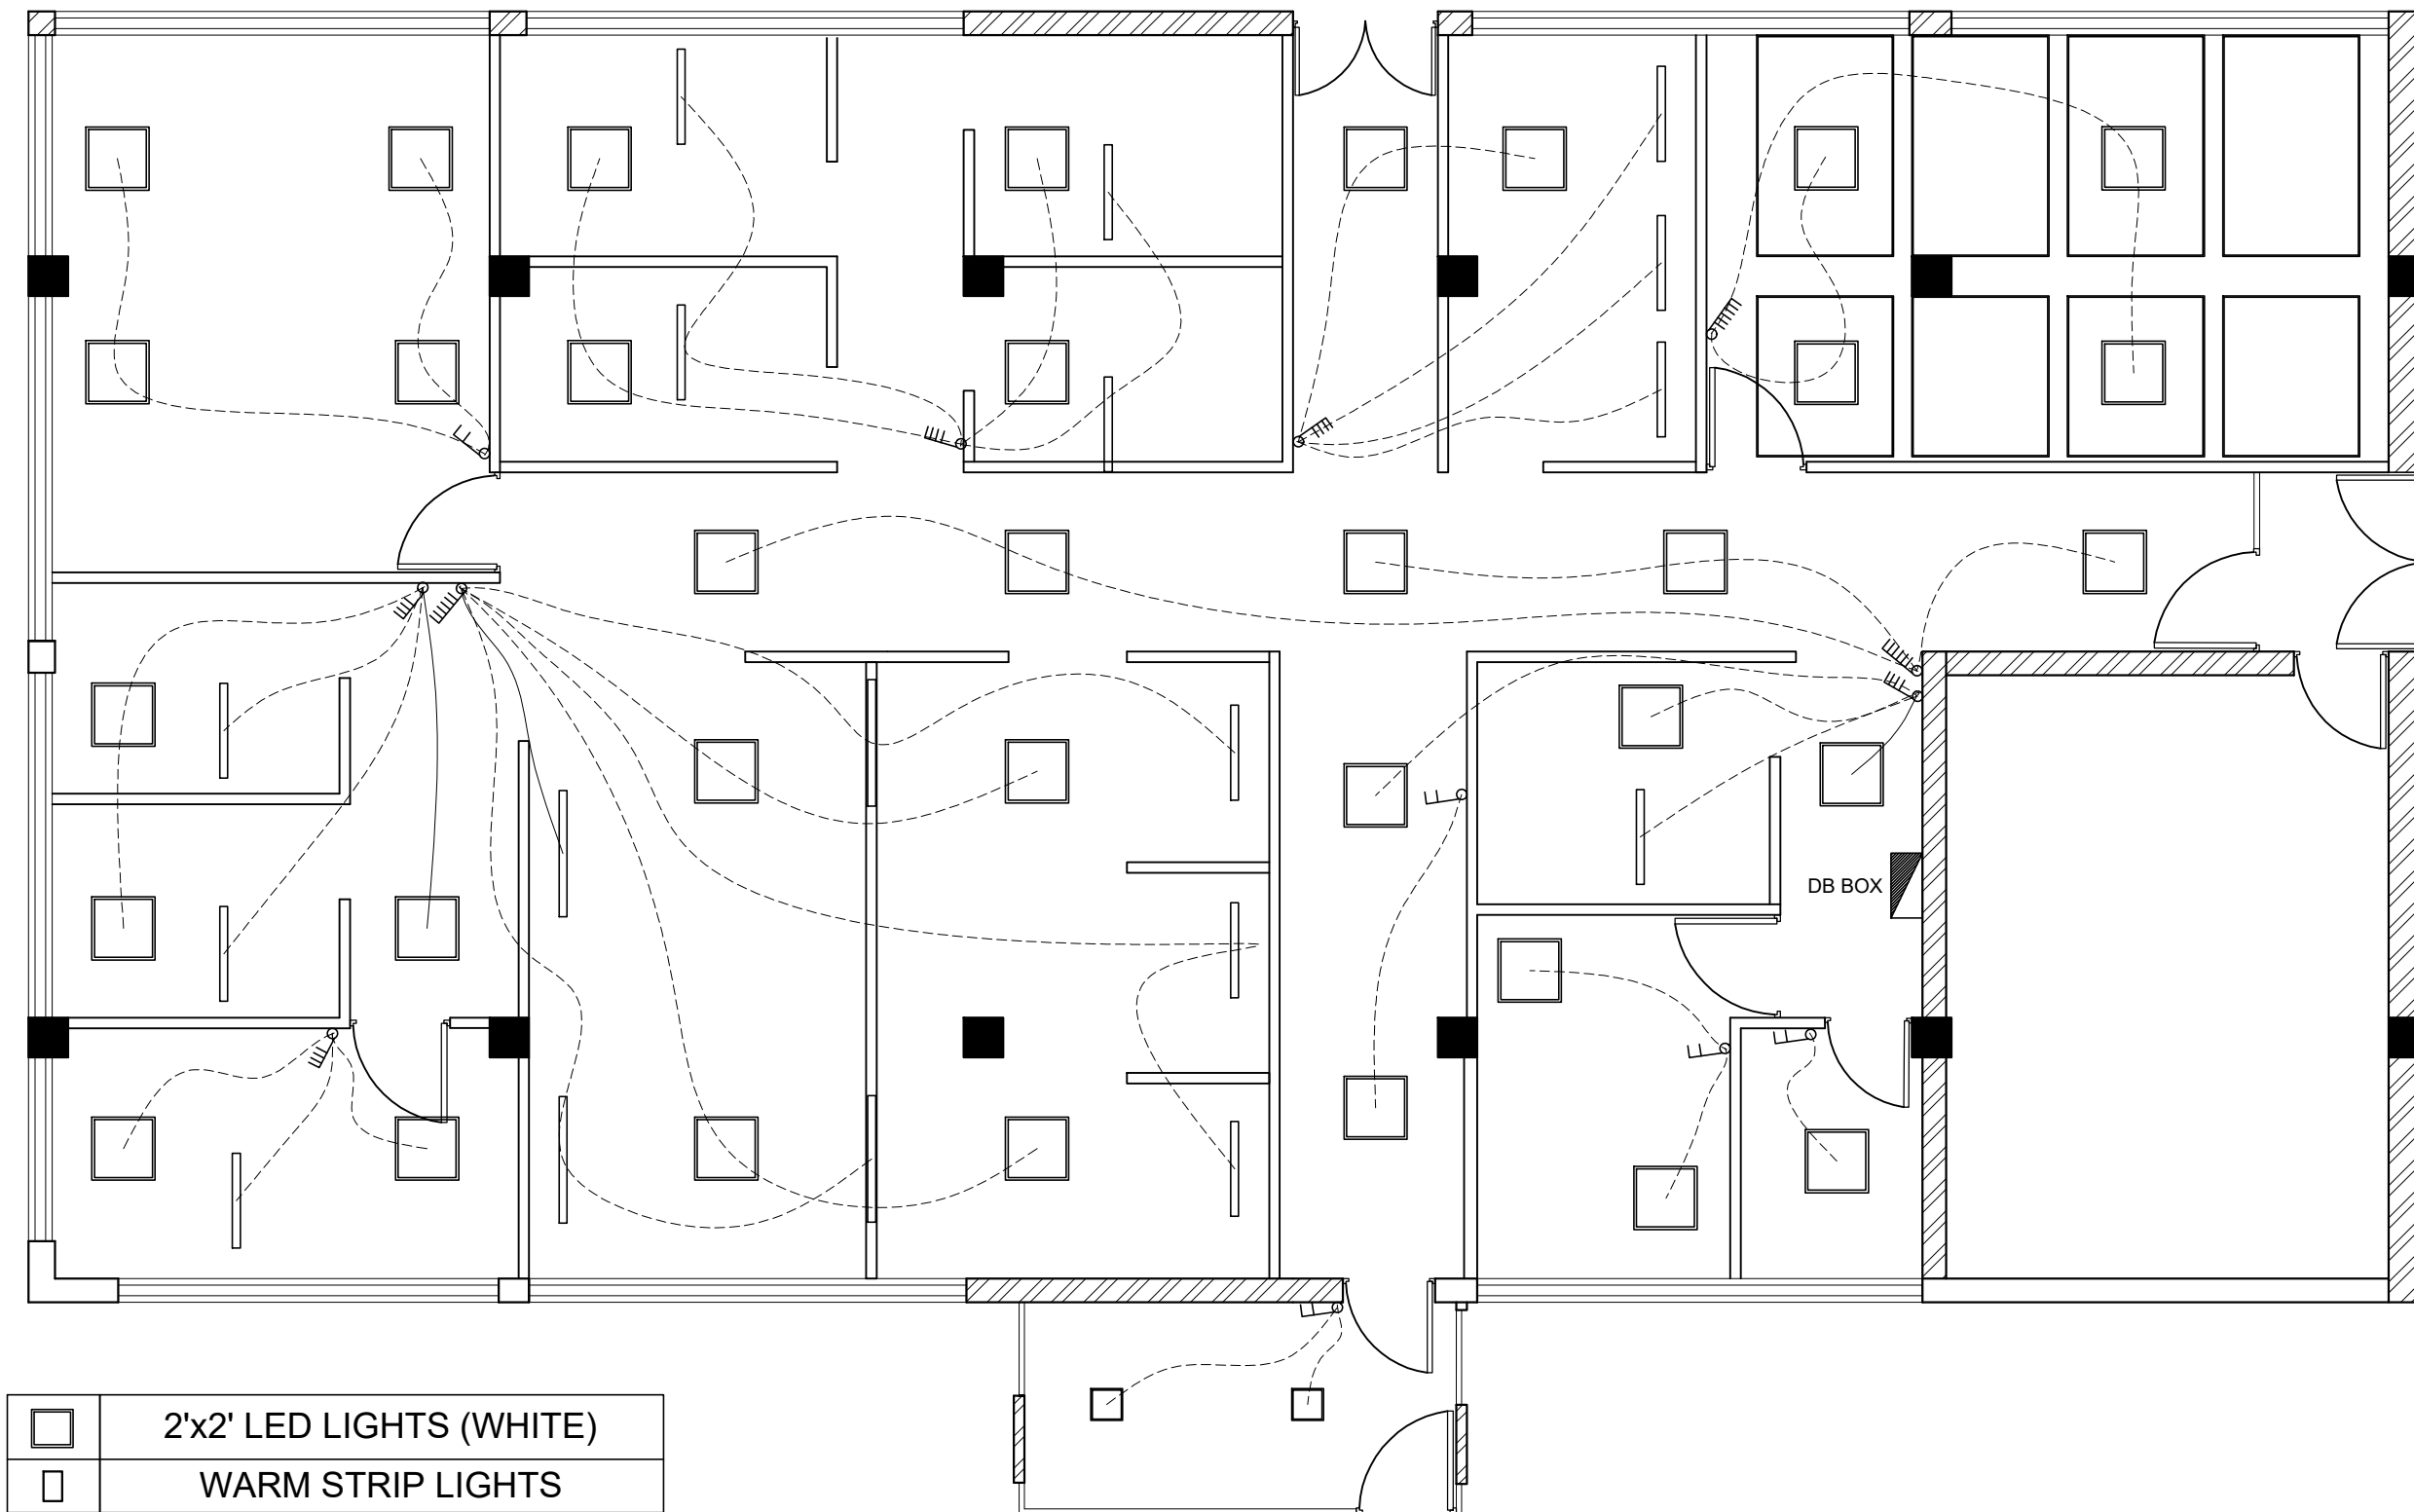

WIRING PLAN SCALE= 1:100

WHO OFFICE

Project Location

UN House
Pulchowk, Lalitpur

Project Type

Design

Project Architect

Drawn By

Note

Sheet Title

WIRING PLAN

Date

NOVEMBER, 2025

A-107

Sheet No.



	2'x2' LED LIGHTS (WHITE)
	WARM STRIP LIGHTS
	4' LENGTH HANGING LIGHTS

WIRING PLAN SCALE= 1:100

WHO OFFICE

Project Location

UN House
Pulchowk, Lalitpur

Project Type

Design

Project Architect

Drawn By

Note

Sheet Title



WIRING PLAN WITH BEAM

Date

NOVEMBER, 2025

A-107'

Sheet No.

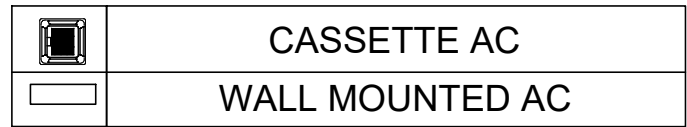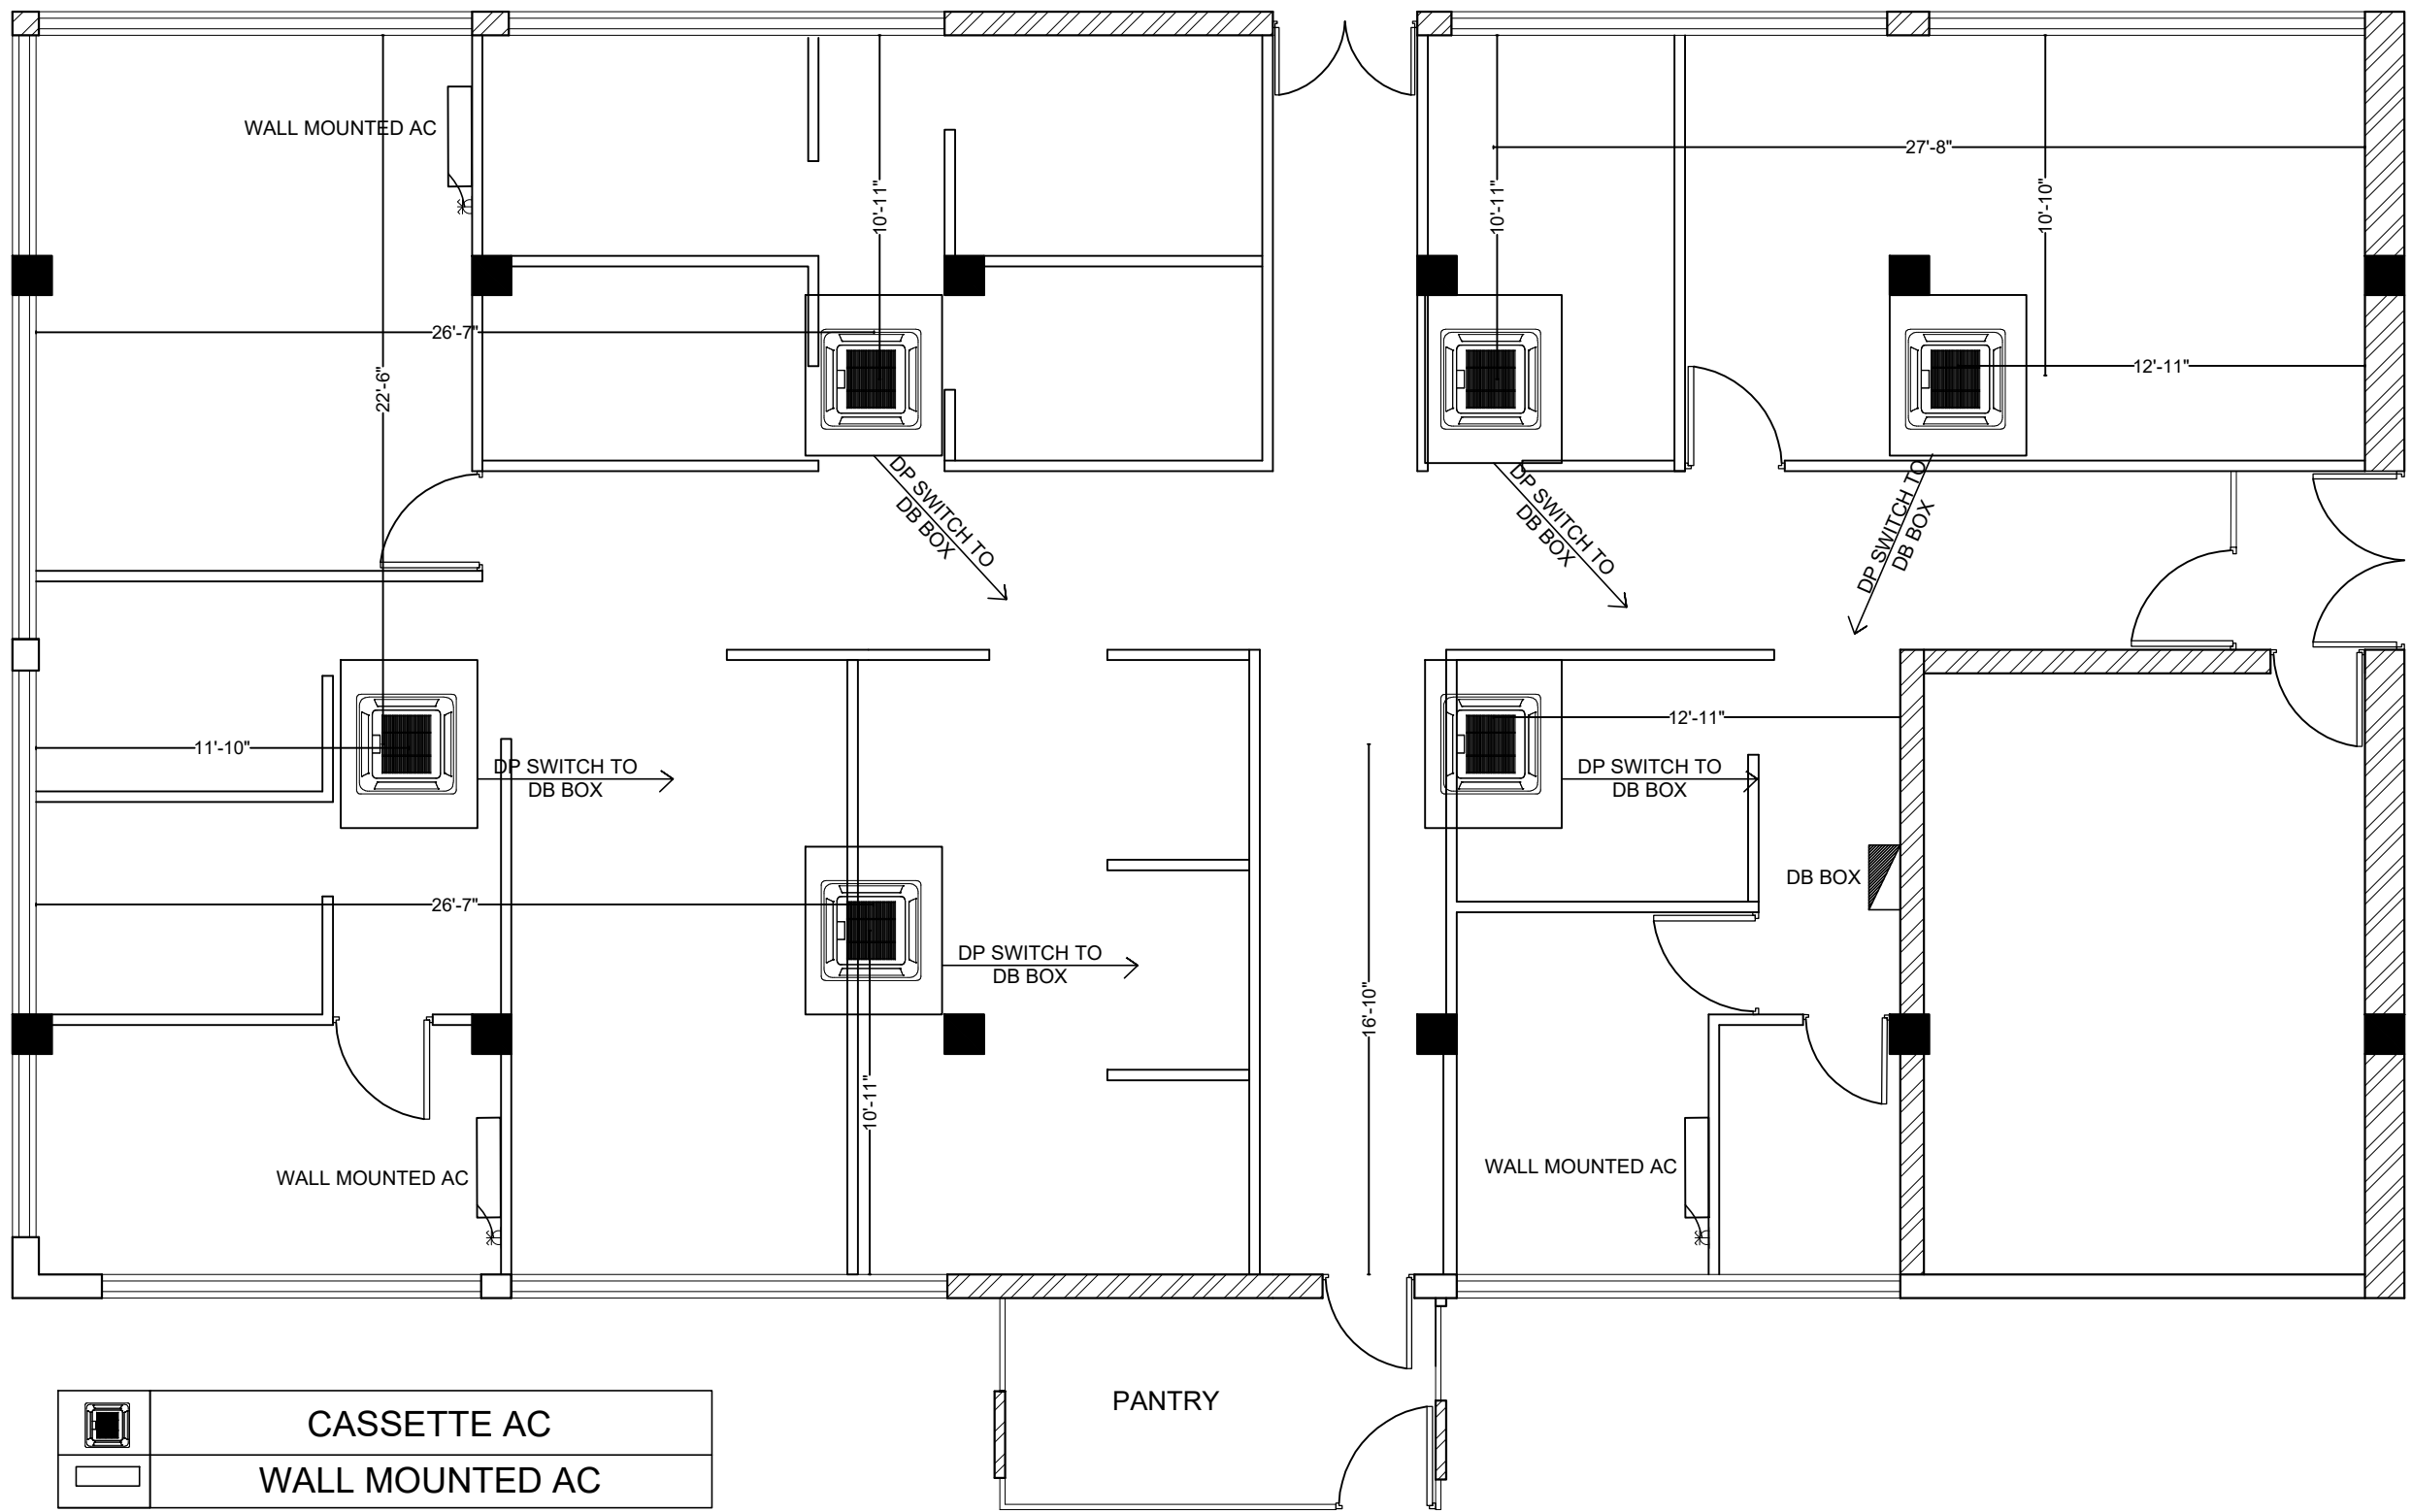

AC LAYOUT PLAN SCALE= 1:100

Project Location
UN House
Pulchowk, Lalitpur

Project Type
Design

Project Architect


Drawn By

Note

Sheet Title
AC LAYOUT PLAN

Date
NOVEMBER, 2025

A-108
Sheet No.

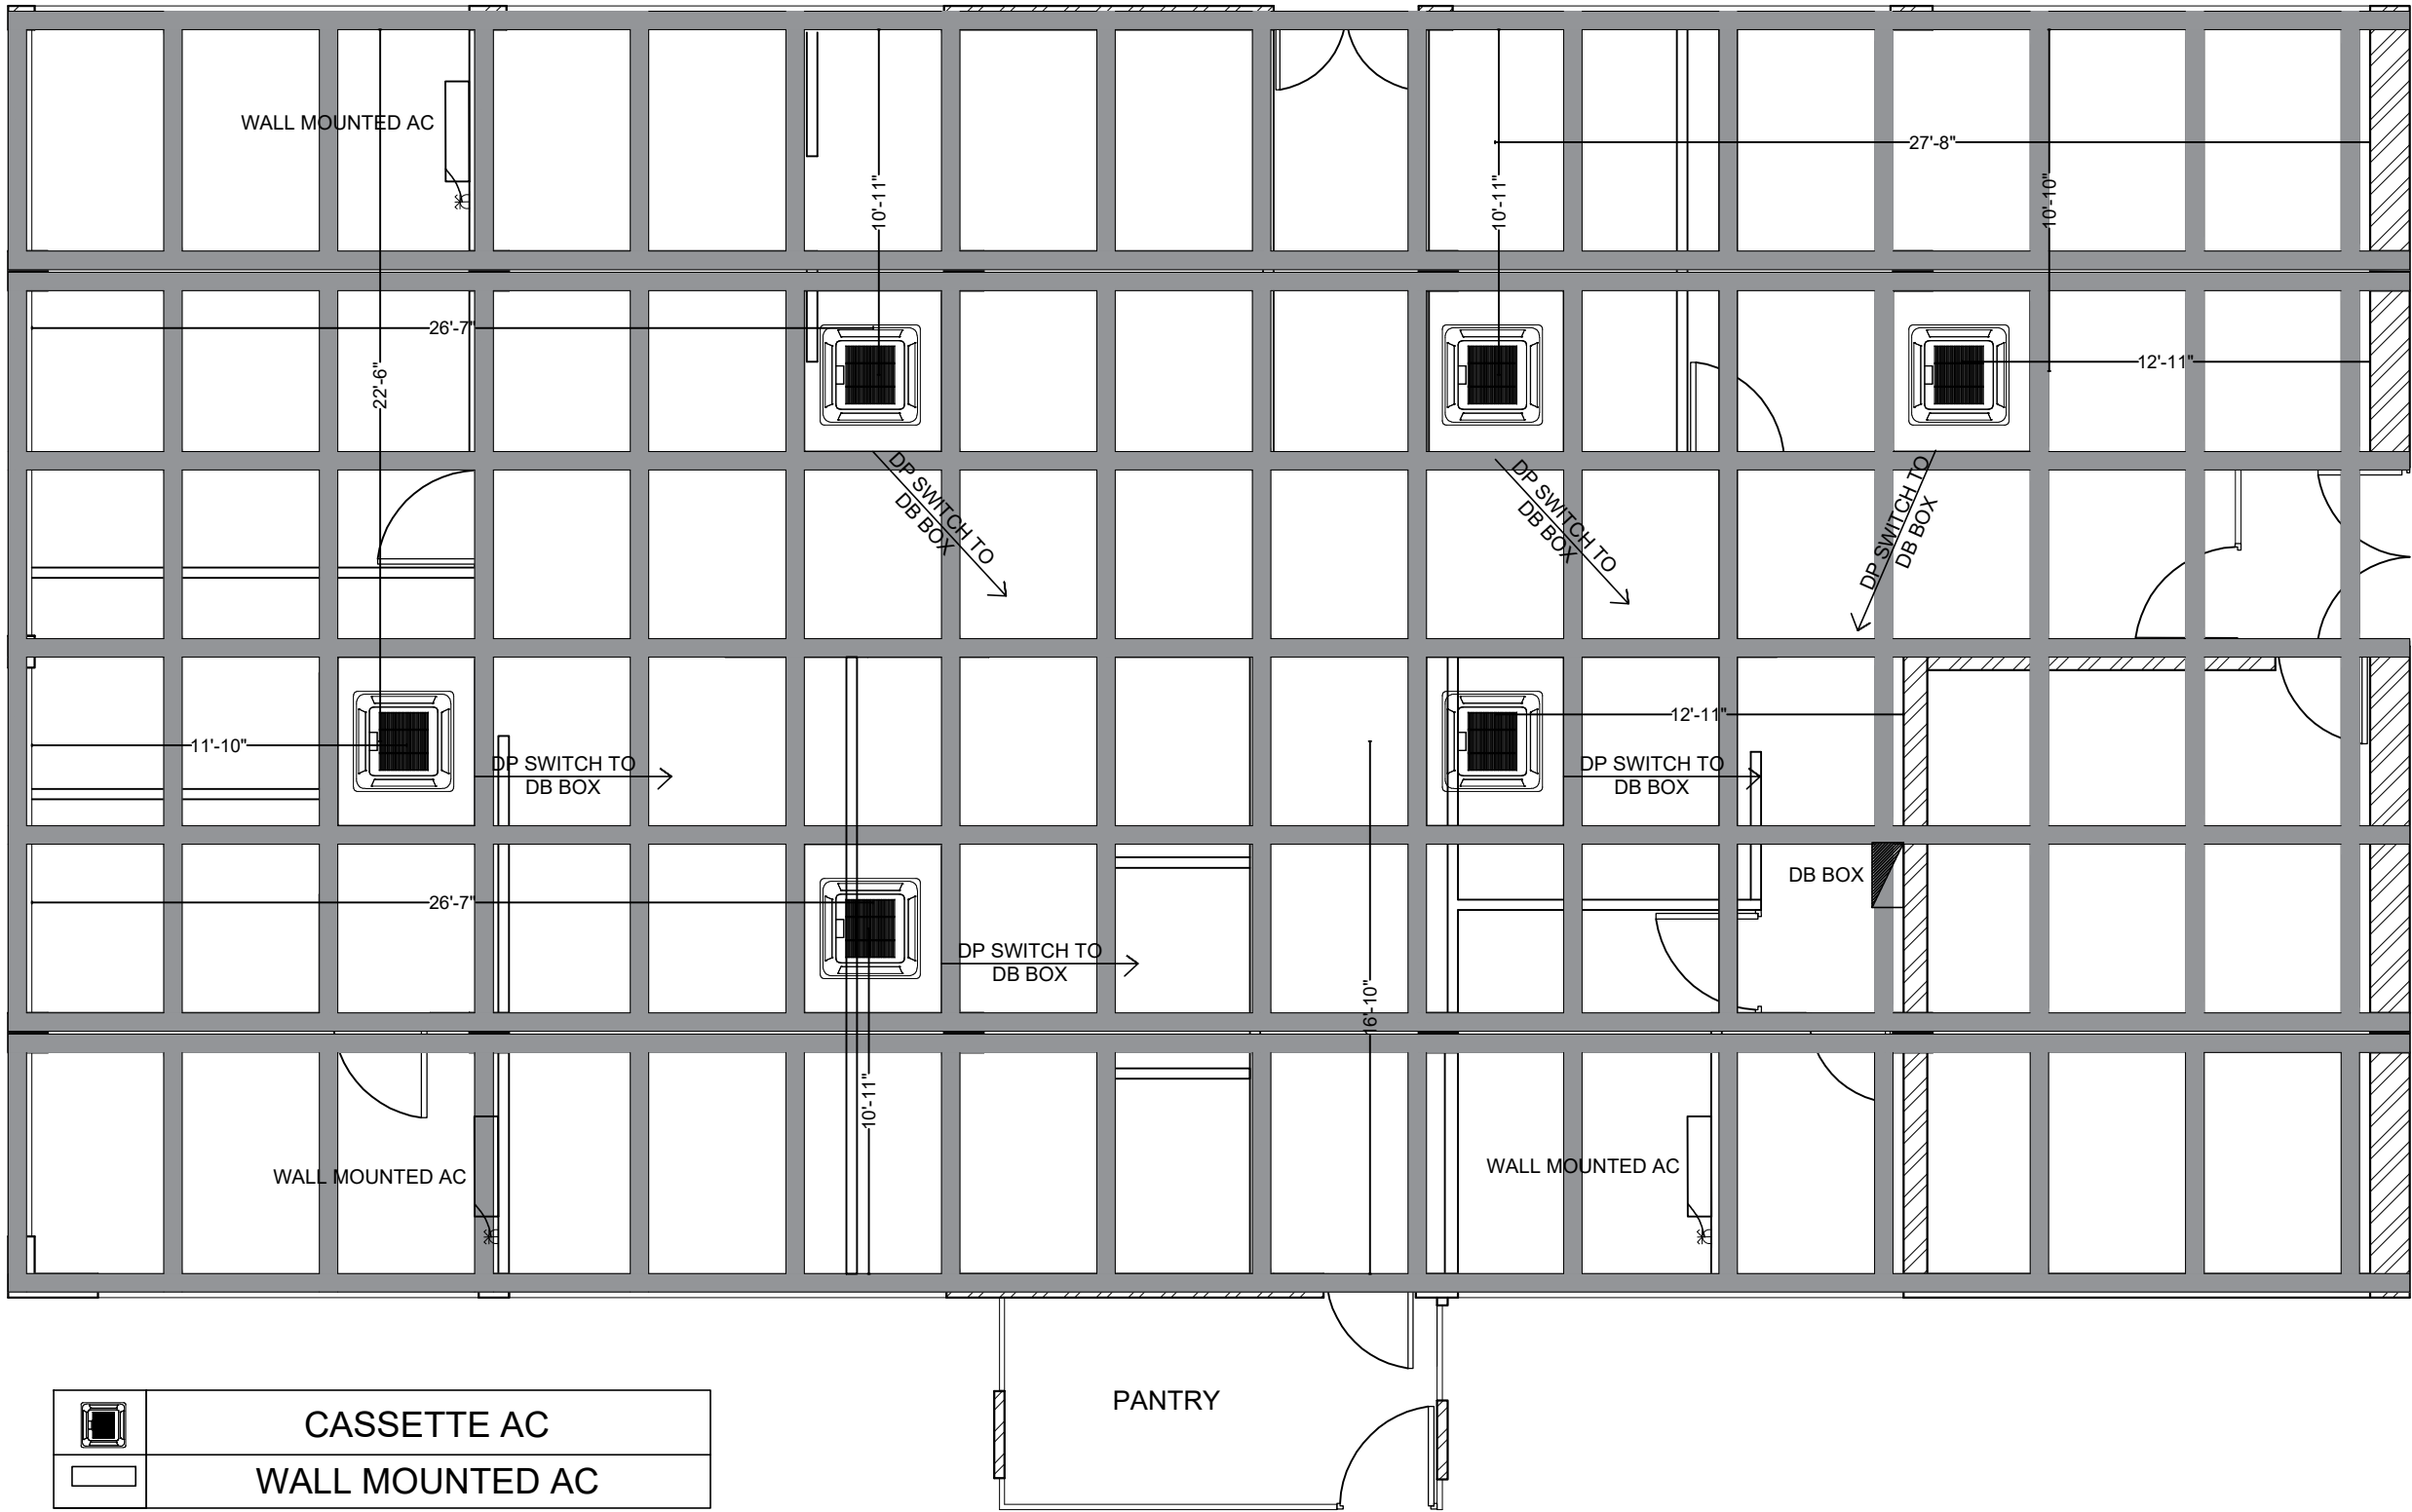

AC LAYOUT PLAN SCALE= 1:100

Project Location

UN House
Pulchowk, Lalitpur

Project Type

Design

Project Architect

Drawn By

Note

Sheet Title

AC LAYOUT PLAN WITH
BEAM

Date

NOVEMBER, 2025

A-108'

Sheet No.